


NOTES:
 ALL REGISTERS 4x10 UNLESS OTHERWISE NOTED
 § =TIMER SWITCH

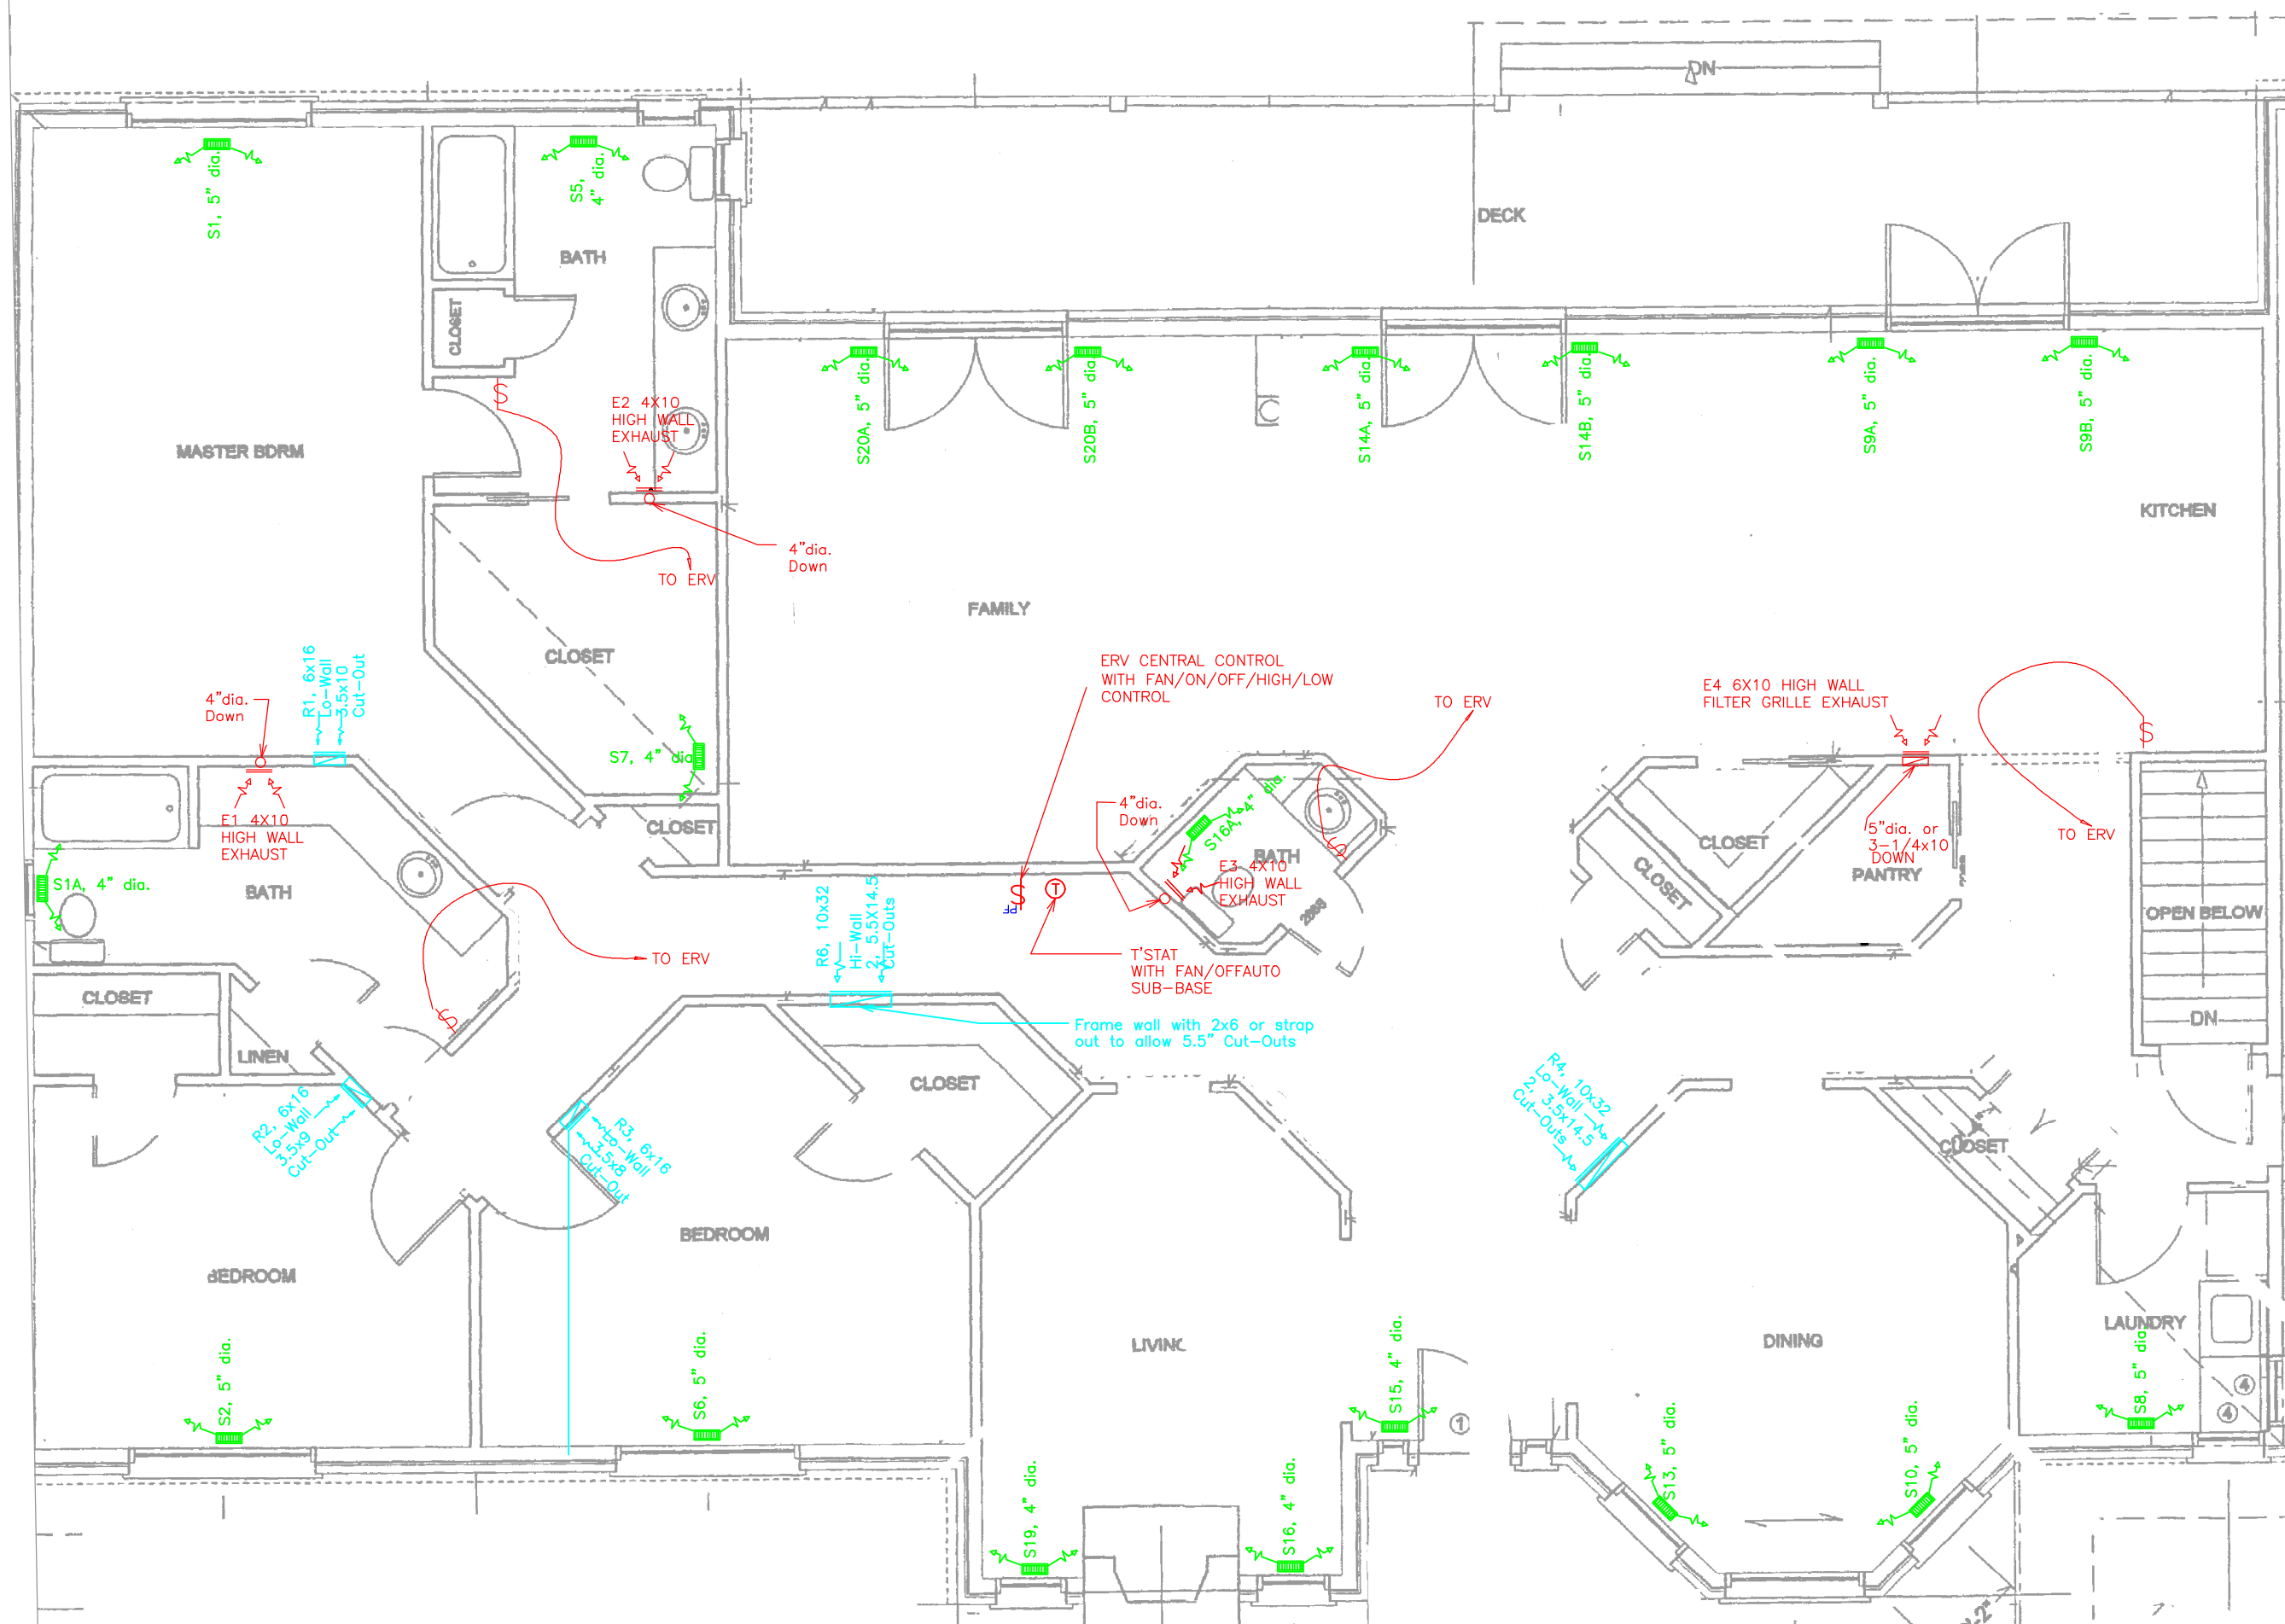

SkilTech **Certificate Holder**
Dara G. Bowser
 VENT1 RHLG
 VENTD RASD
 001527 October 31, 2001
 CERTIFICATE NO EXPIRY DATE
 SIGNATURE **NOT VALID UNLESS SIGNED**
 FOR EXPLANATION OF CODES SEE OVER

DATE: ISSUED FOR:

DRAWING ISSUED FOR THE THE USE OF CLIENT NAME GOES HERE AND MAY NOT BE USED BY OTHER PERSONS WITHOUT AUTHORIZATION. DRAWINGS FOR PERMIT AND CONSTRUCTION ARE SIGNED IN RED INK.


NOTE: DRAWING FOR HEAT LOSS & VENTILATION SYSTEMS ONLY. ALL DIMENSIONS APPROXIMATE DO NOT SCALE.

PROJECT: **SAMPLE HOUSE**

TITLE: **MAIN FLOOR DUCTWORK LAYOUT**

SCALE: **3/16" = 1'-0"** DWG. NO: **9938-3A**

BOWSER TECHNICAL INC
 222 Memorial Drive,
 Brantford, Ontario N3R 5T1
 (519) 756-9116 Fax: 756-9227

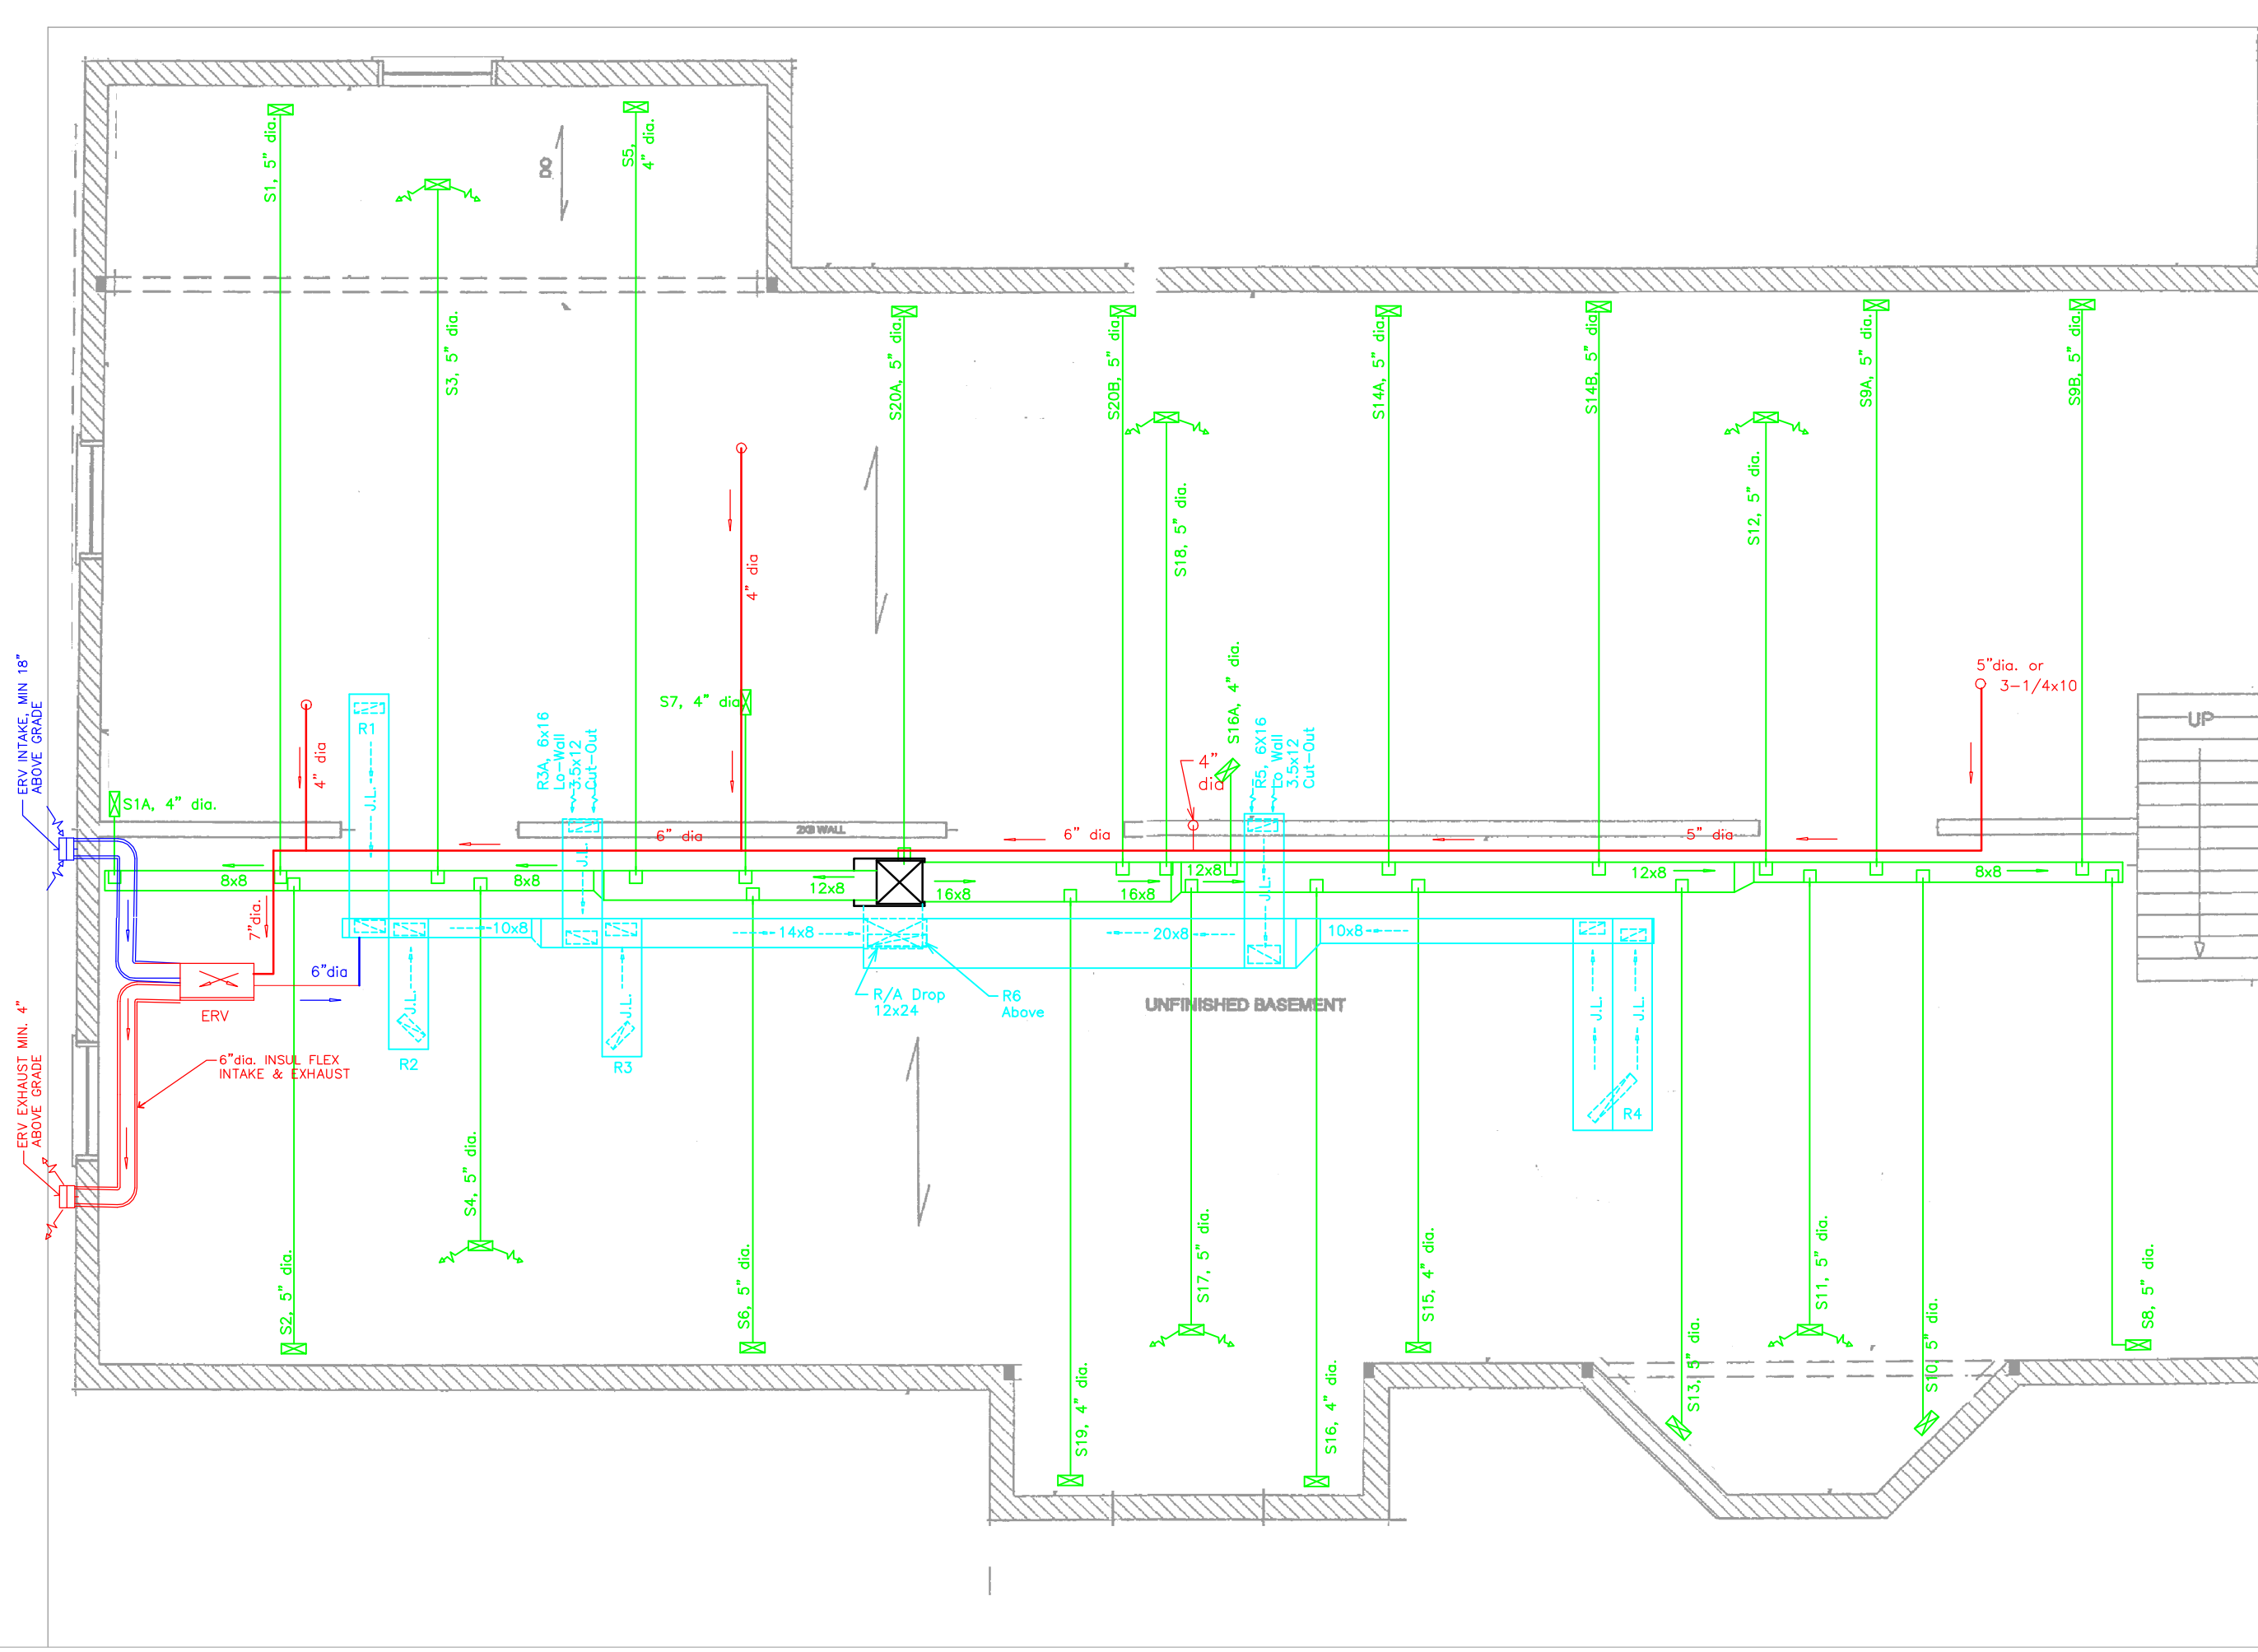

NOTES:
 ALL REGISTERS 4x10 UNLESS OTHERWISE NOTED
 CUTOUTS FOR RETURN AIR TRUNK TO BE 1-1/2 TO 2 TIMES THE AREA OF THE FLOOR CUTOUT NOTED ON THE DRAWING AT THE STACK LOCATION.
 SEE PAGE 1 OF THE DUCT DESIGN CALCULATIONS FOR THE EQUIPMENT SPECIFICATIONS

SkillTech
 Mechanical
 Ductwork Installation
 Dara G. Bowser
 VENT RHLG
 VENTD RASO
 901527 October 31, 2001
 CERTIFICATE NO EXPIRY DATE
 SIGNATURE **NOT VALID UNLESS SIGNED**
 FOR EXPLANATION OF CODES SEE OVER

DATE:	ISSUED FOR:

DRAWING ISSUED FOR THE THE USE OF **CLIENT NAME GOES HERE** AND MAY NOT BE USED BY OTHER PERSONS WITHOUT AUTHORIZATION. DRAWINGS FOR PERMIT AND CONSTRUCTION ARE SIGNED IN RED INK.
 NOTE: DRAWING FOR HEAT LOSS & VENTILATION SYSTEMS ONLY. ALL DIMENSIONS APPROXIMATE DO NOT SCALE.

PROJECT:
SAMPLE HOUSE

TITLE:
BASEMENT DUCTWORK LAYOUT

SCALE: 3/16" = 1'-0"	DWG. NO.: 9938-3B
--------------------------------	-----------------------------

BOWSER TECHNICAL INC
 222 Memorial Drive,
 Brantford, Ontario N3R 5T1
 (519) 756-9116 Fax: 756-9227